

Path Concept House

2503 Parker Street,
Omaha, NE 68111.

Torti Gallas and Partners, Inc.
1300 Spring Street,
4th Floor
Silver Spring, MD 20910
301.588.6800
www.tortigallaschik.com

Owner
Brighton Construction Co
Phone: 402.434.2456
Fax: 402.434.2458
1941 K Street
Lincoln, NE 68510

Project Management
Newport Partners LLC
Phone: 301.888.0017
Fax: 301.888.0018
3780 Tangewood Lane
Davidsonville, MD 21035
www.newportpartnersllc.com

These construction documents were prepared specifically for the project site located at 2503 Parker Street, Omaha, NE. Subsequent use and/or modification of these documents for any project is strictly prohibited unless the documents are reviewed, modified and sealed by a registered architect in the jurisdiction of the proposed project for code compliance, constructability and site adaptation; the project is a HUD project; and, all users and the registered architect agree to defend, indemnify, and hold harmless Torti Gallas And Partners, Inc., its successors and the past, present and future employees of all of them, from all claims, losses, damages, judgments, cost, including reasonable attorney fees, and expenses that relate to or arise, in any way, out of the use or modification of the documents for other projects. Torti Gallas And Partners, Inc. retains all common law and statutory copyrights in these documents and their content. Any copying, use or modification of these documents without strict adherence to these conditions will be prosecuted as a violation of these copyrights.

Key Plan

Revisions

No. 01 Date 11/24/06
General Revisions

Roof & Basement Floor Plan

Date 10/31/06

Principal In Charge B.K.

Project Designer M.B.

Project Architect F.S.



Drawn B.K., F.S.

Job No. 05127.03

Scale 1/4" = 1' - 0"

Drawing No.

A201

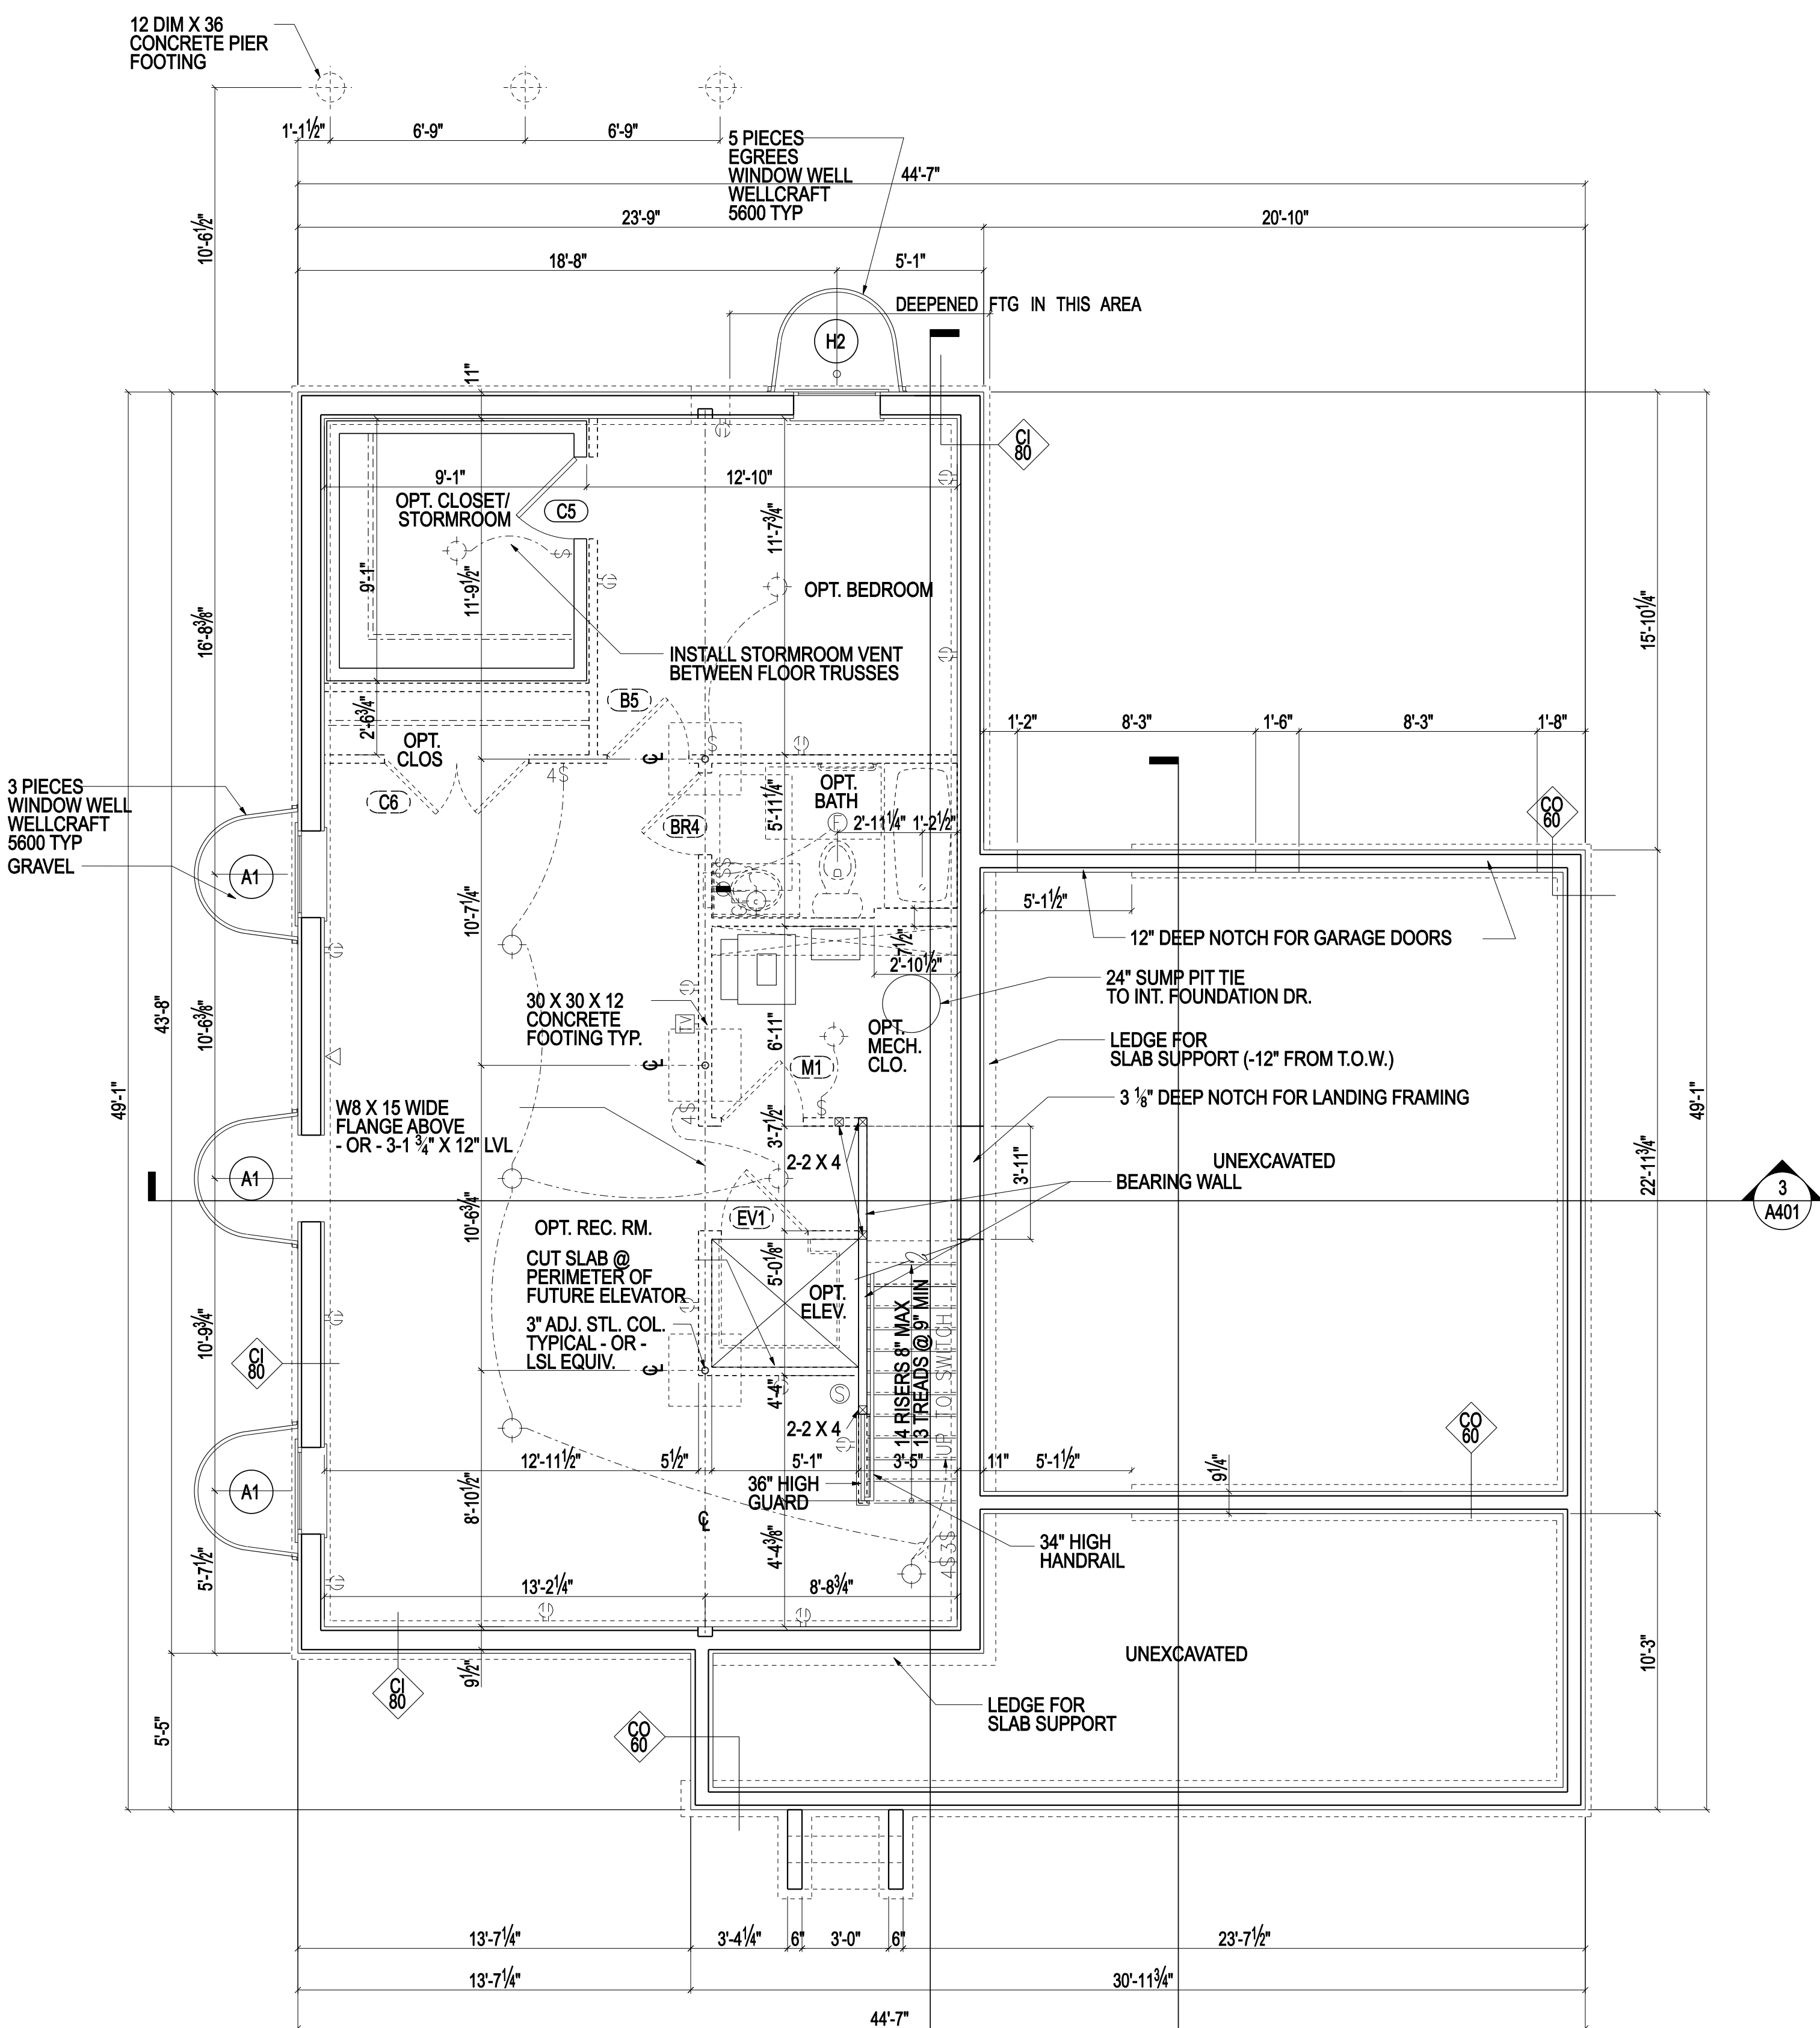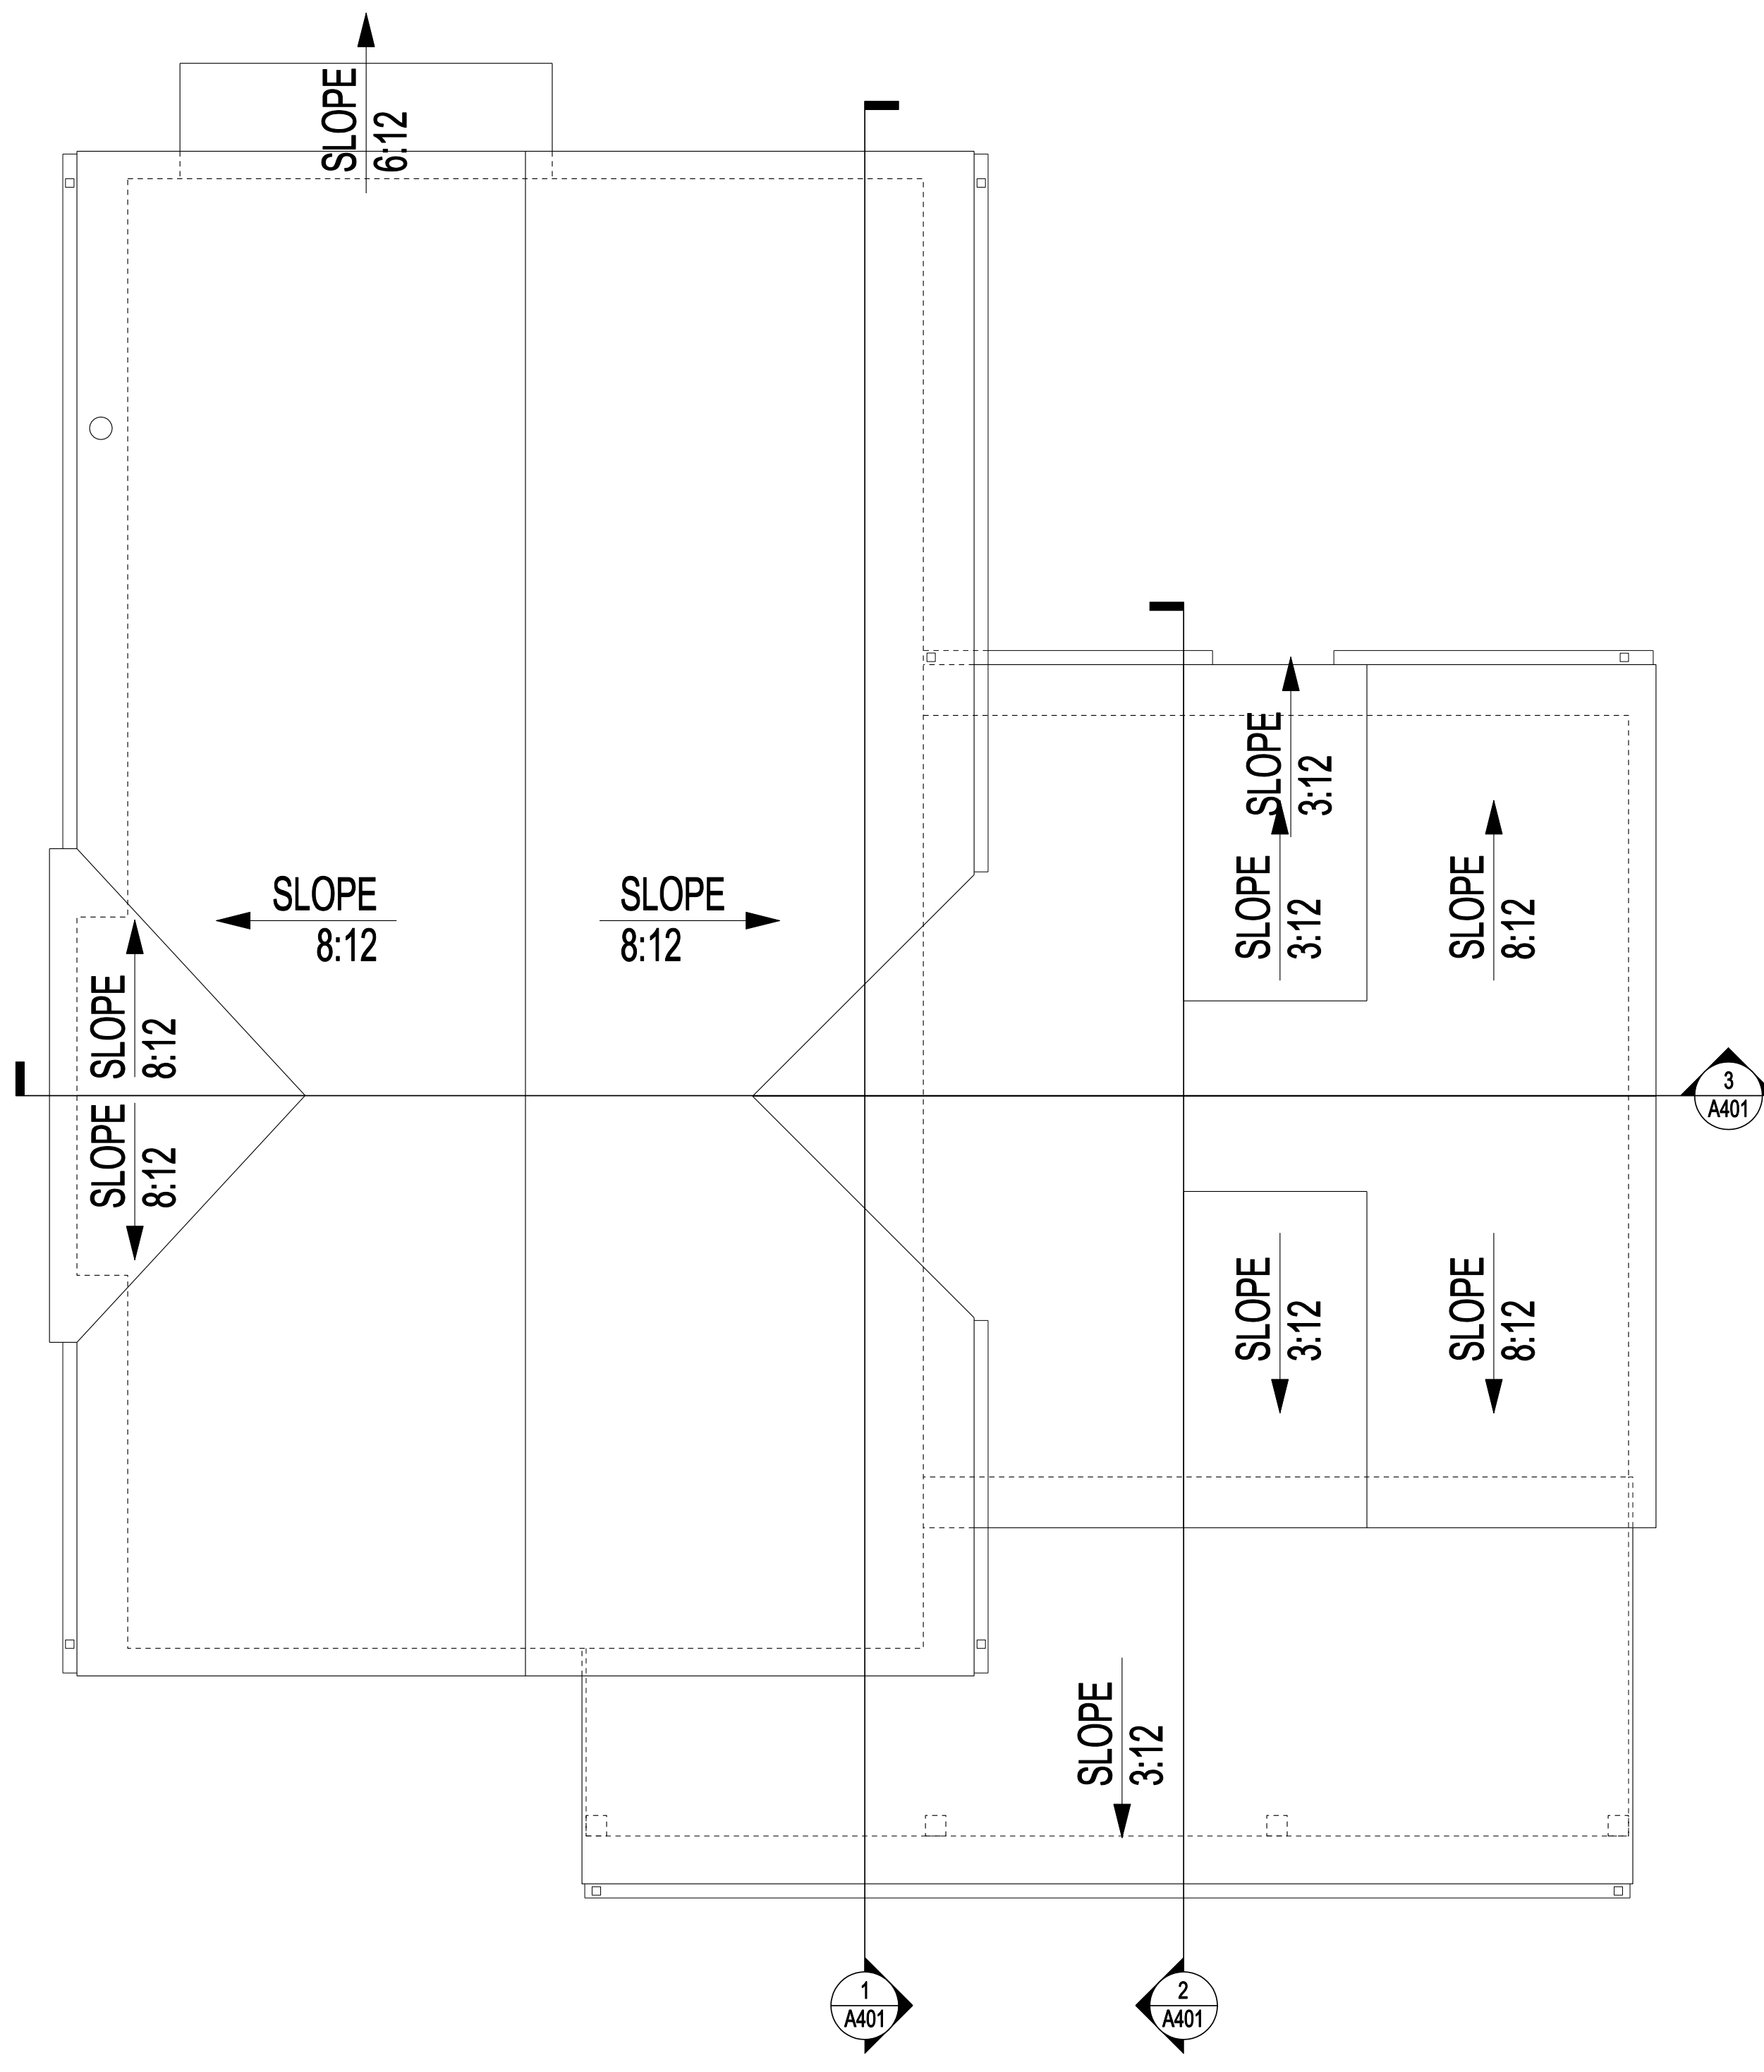

ELECTRICAL LEGEND			
DUPLEX OUTLET	⊕	SWITCH	⊞
DUPLEX OUTLET @ 44" A.F.F.	⊕	3-WAY SWITCH	⊞
GROUND FAULT INTERRUPTED @ 30" A.F.F.	⊕	CEILING MOUNTED LIGHT FIXTURE	⊙
GROUND FAULT INTERRUPTED @ 44" A.F.F.	⊕	WALL MOUNTED LIGHT FIXTURE	⊙
WATERPROOF DUPLEX OUTLET	⊕	UNDER-CABINET LIGHTS	⊕
CEILING DUPLEX OUTLET	⊕	TRACK LIGHTING	⊕
TELEPHONE OUTLET	⊕	EXHAUST FAN	⊕
TELEVISION/DATA OUTLET	⊕	SMOKE DETECTOR	⊕
FAN/LIGHT	⊕	JUNCTION BOX	⊕
		ELECTRICAL PANEL	⊕

Users: c:\p05127\ep\03\march\sh\CPH04201.SHT
File: 3/9/2007 2:02:45 PM
Time: 2:02:45 PM
User: f.s.
Driver: PFD_20042.rlt

TORTI GALLAS AND PARTNERS, INC. PATH CONCEPT HOUSE